




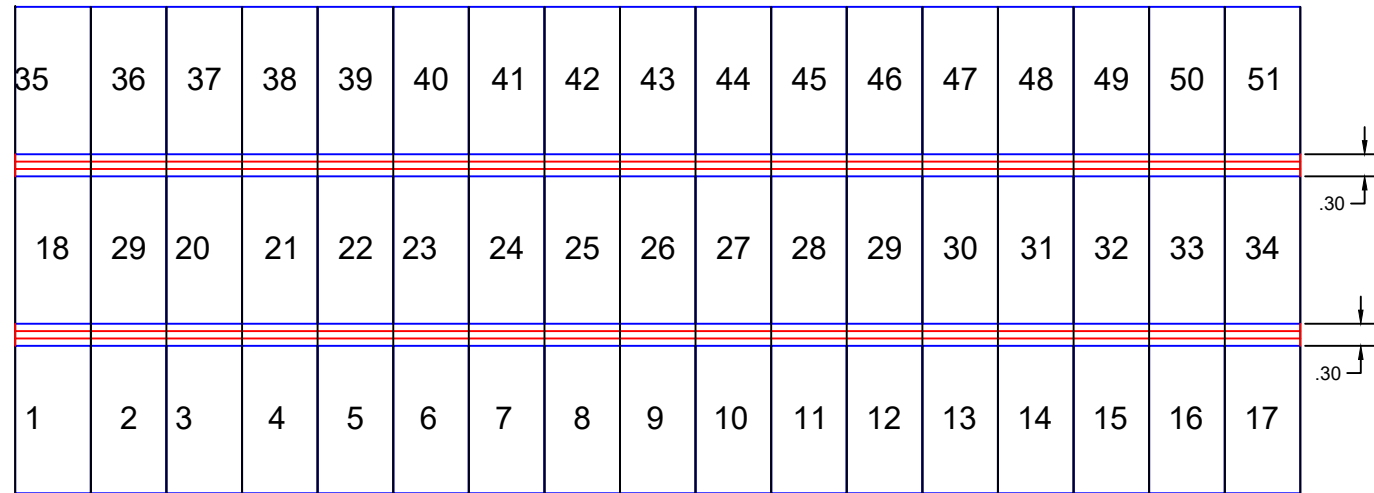


TOP VIEW

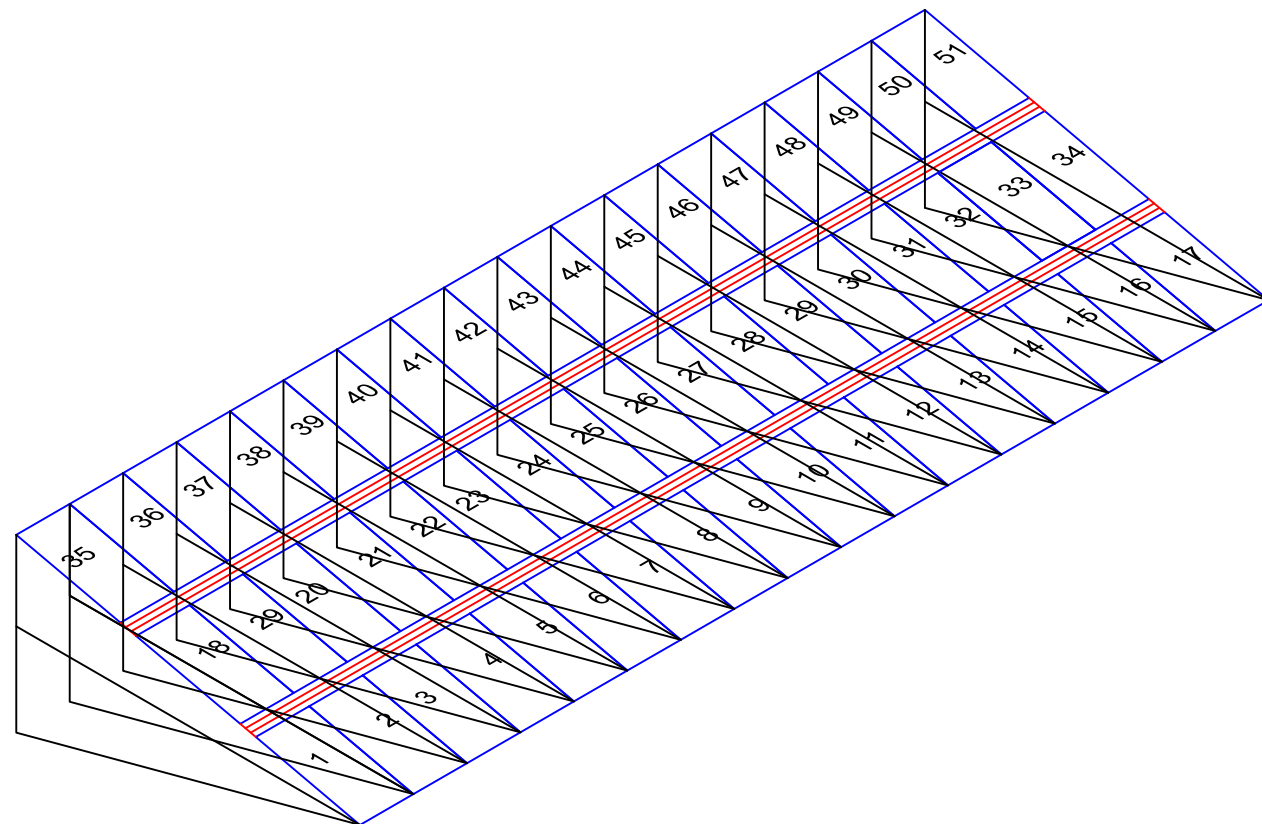

ISOMETRIC VIEW

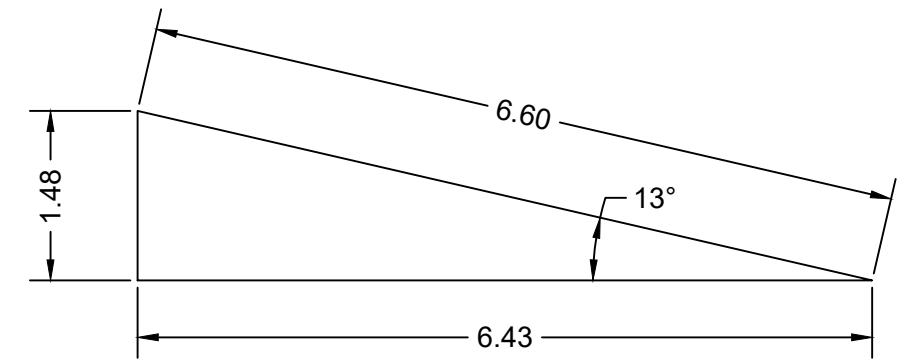

CROSS SECTION

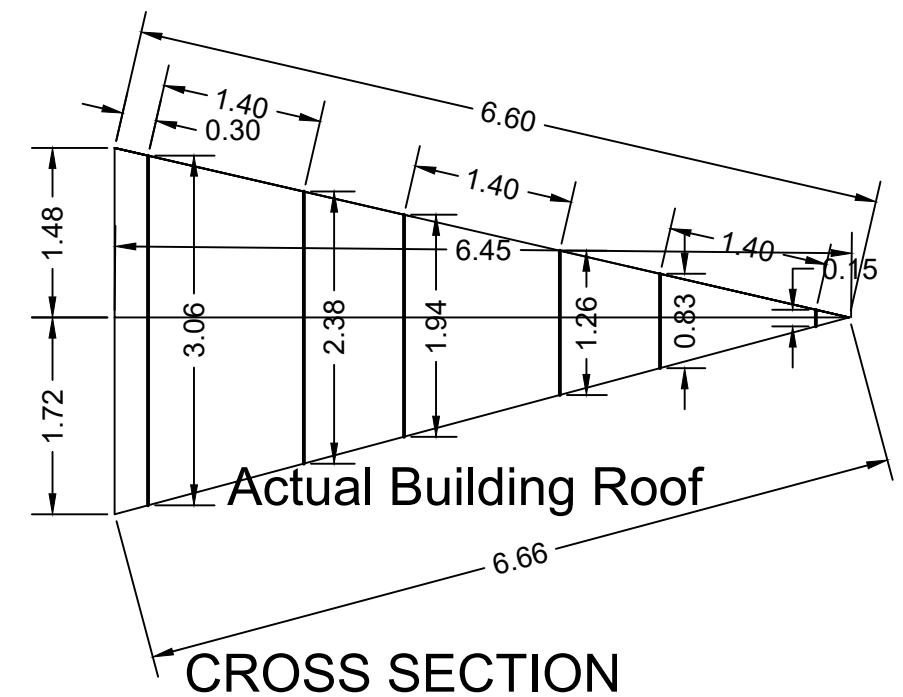

CROSS SECTION

 VIRGIN POWER & ENGINEERING	CLIENT NAME : JOBY JOSEPH	This drawing is the property of VIRGIN POWER AND ENGINEERING PVT LTD and the information therein is not to be used or copied without written authorization of VIRGIN POWER AND ENGINEERING PVT LTD		DRAWING NAME : SOLAR POWER PLANT FOR JOSONS HARDWARES		
PROJECT : 20 KW SOLAR POWER PLANT, CHALAKKUDY	DESIGNED BY : ASHRAF ALI		DATE: 12-02-2021	SIZE A3	DRAWING NO. : VPE1006	REV. : 00
	DRAWN BY : ASHRAF ALI		DATE: 13-02-2021		SHEET : 1 OF 1	
	CHECKED BY : ANIL KUMAR		DATE: 15-02-2021			
	APPROVED BY : SAJI THOMAS		DATE: 16-02-2021	SCALE : 1: 100, NOT TO SCALE		