



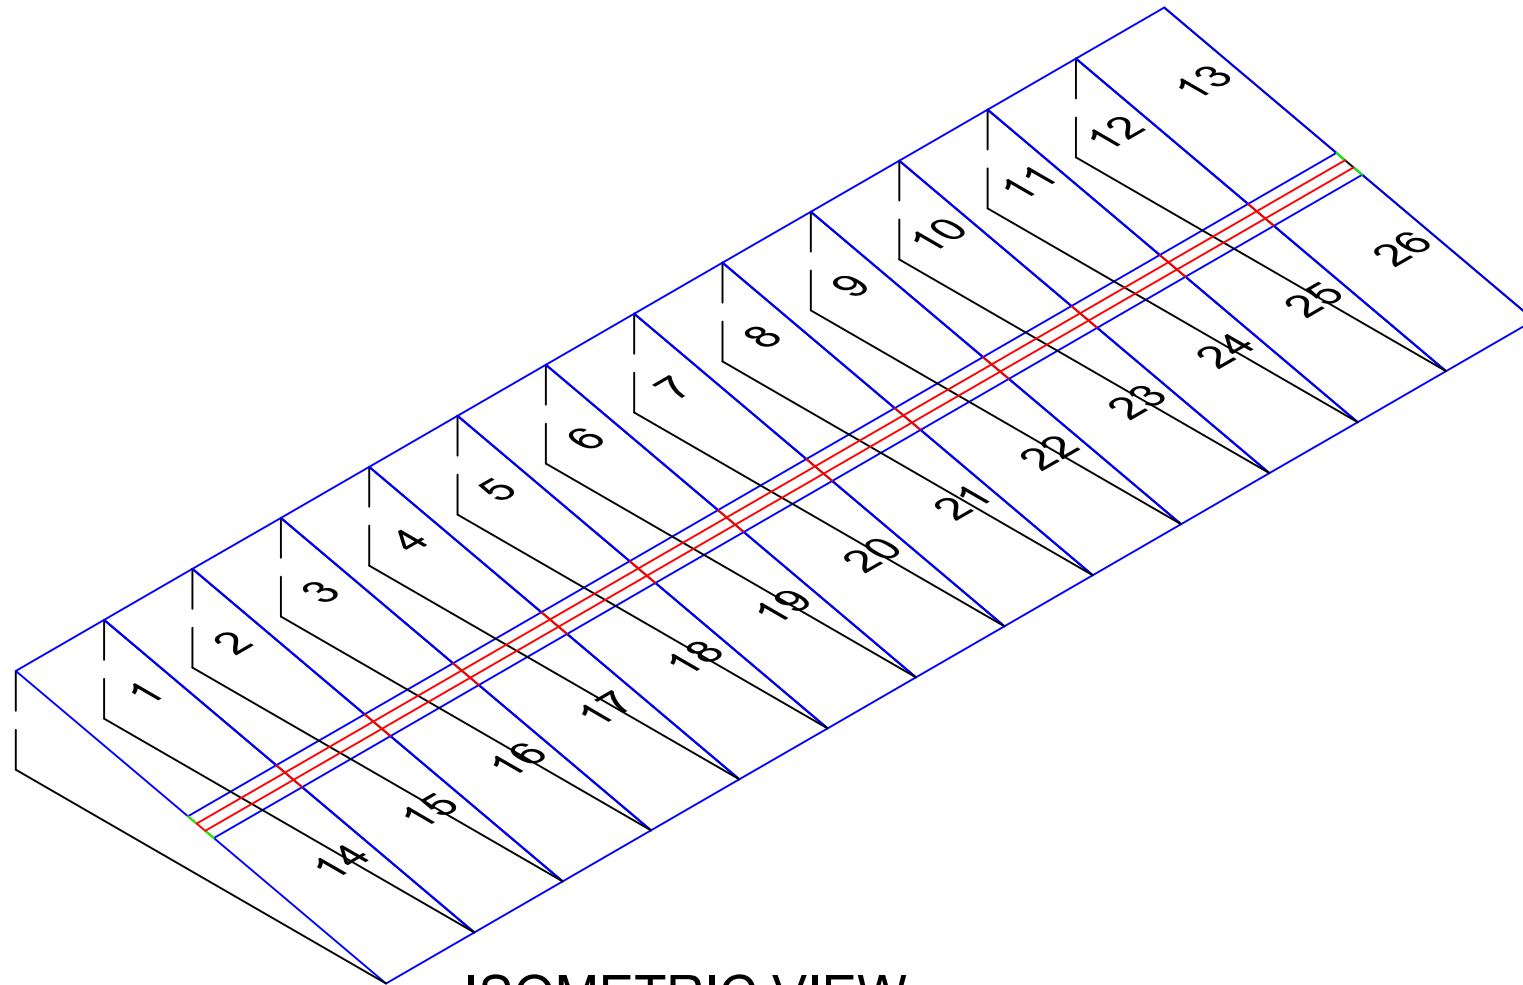


ISOMETRIC VIEW

1	2	3	4	5	6	7	8	9	10	11	12	13
14	15	16	17	18	19	20	21	22	23	24	25	26

TOP VIEW

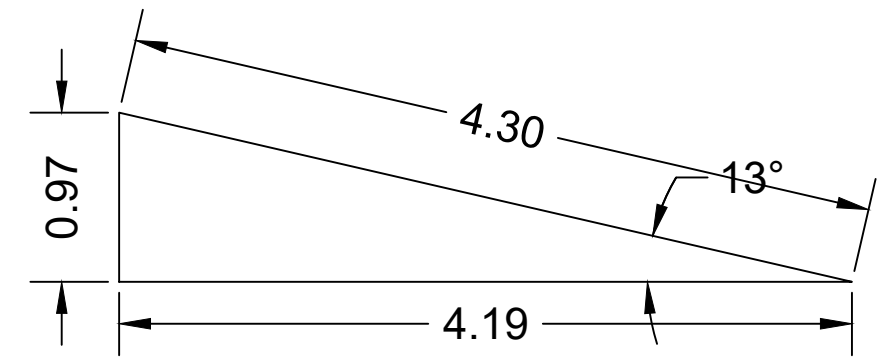

CROSS SECTION A-A

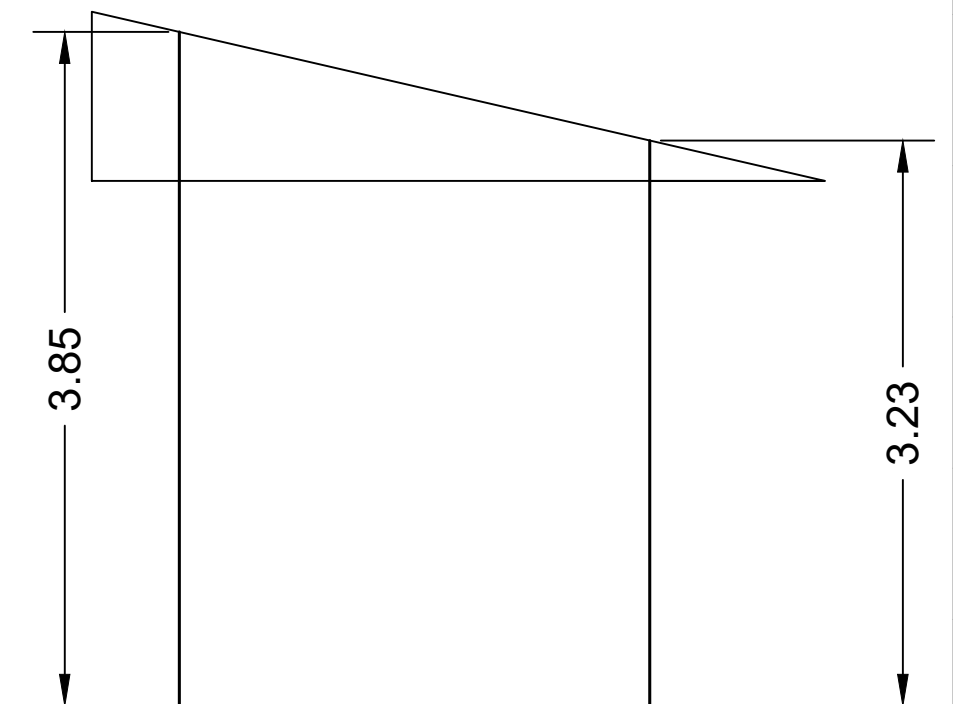

CROSS SECTION B-B

 VIRGIN POWER & ENGINEERING	CLIENT NAME :	This drawing is the property of VIRGIN POWER AND ENGINEERING PVT LTD and the information therein is not to be used or copied without written authorization of VIRGIN POWER AND ENGINEERING PVT LTD.		DRAWING NAME :						
	MV RAJESH			SOLAR POWER PLANT						
	PROJECT :			DESIGNED BY : ASHRAF ALI	DATE: 18-01-201	SIZE A3	DRAWING NO. : VPE007	REV. : 00		
	10 KW SOLAR POWER PLANT, RANNI			DRAWN BY : ASHRAF ALI	DATE: 21-01-2021					
				CHECKED BY : ANIL KUMAR	DATE: 21-01-2021					
APPROVED BY : SAJI THOMAS				DATE: 22-01-2021	SCALE : NOT TO SCALE					
14	15	16	17	18	19	20				